




# Horizontal Powerflue Detail

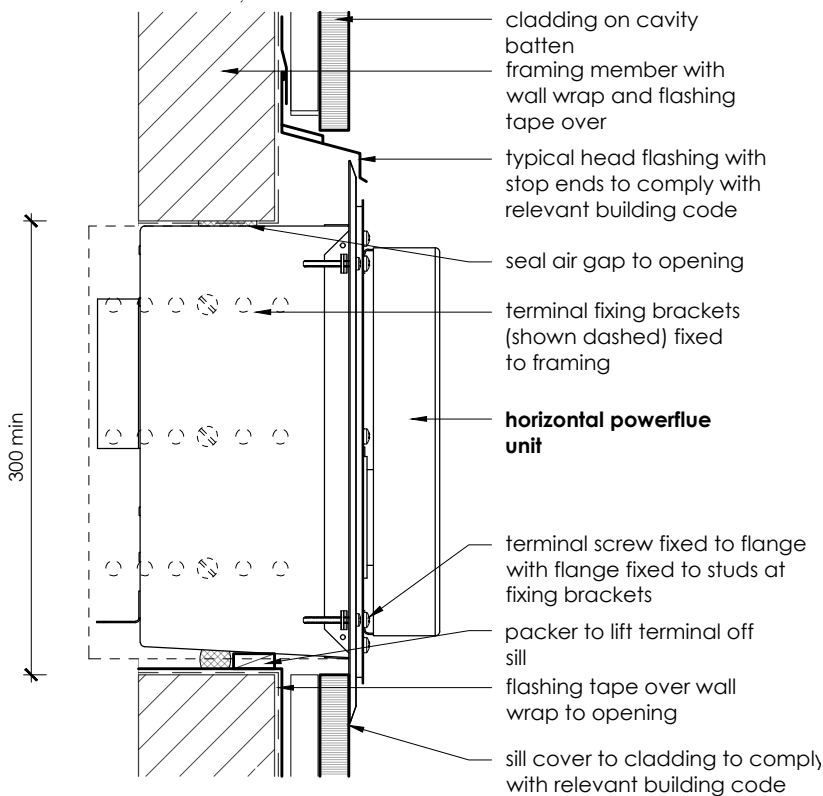


**Head and Sill** scale 1:5

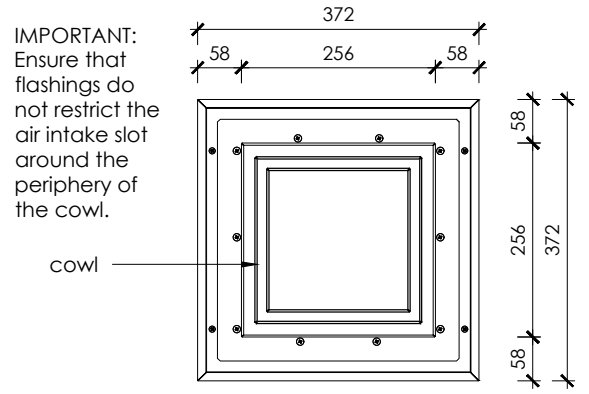


**Front Elevation** scale 1:10

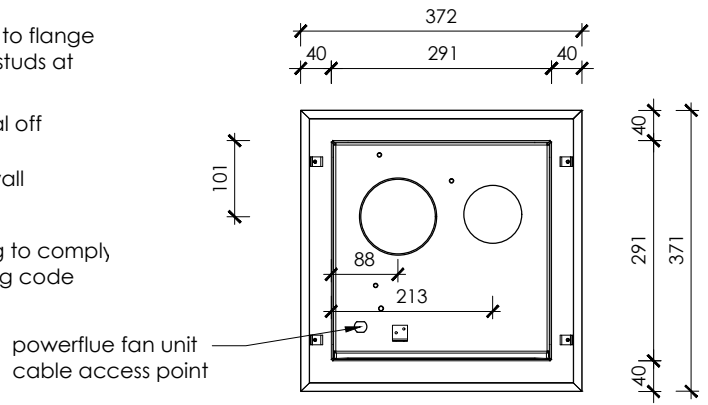

**Rear Elevation** scale 1:10

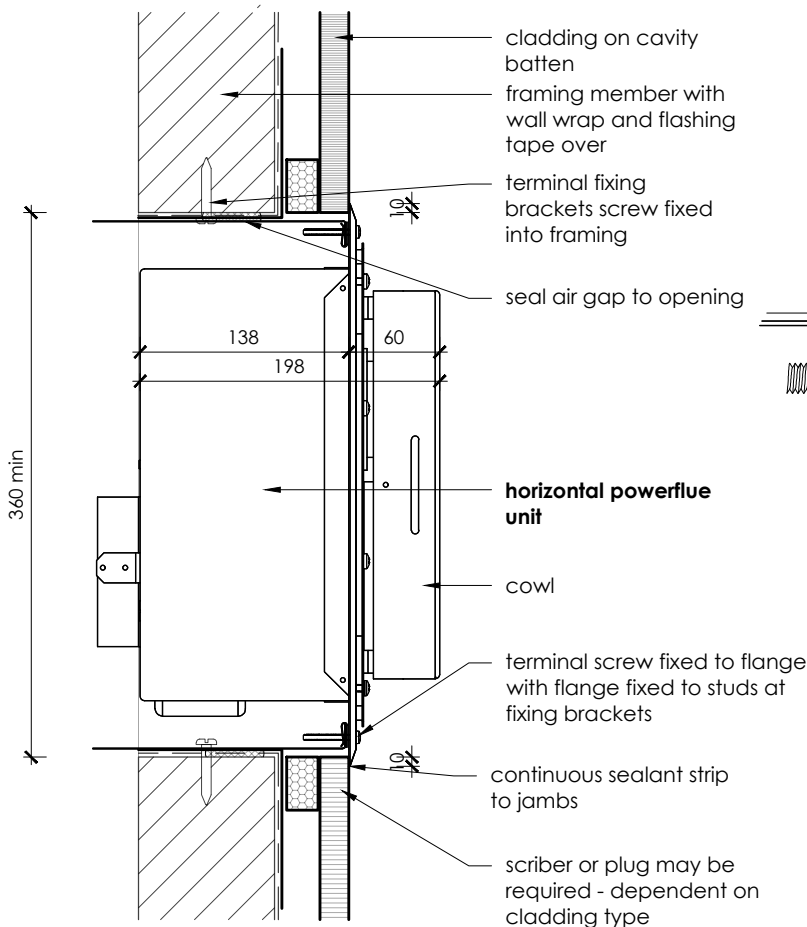

**Jamb** scale 1:5

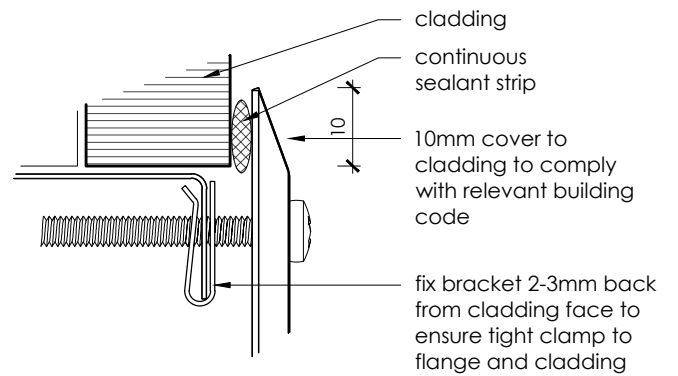

**Fixing Detail** scale 1:1

**IMPORTANT:**  
This technical sheet must be read in conjunction with the requisite Escea D-Series Gas Fire Installation Manual, the latest version can be found on our website [www.escea.com/nz/technical/](http://www.escea.com/nz/technical/)  
**Contact the ESCEA Architectural Advisory Team for assistance with installation of this fire - [aa@escea.com](mailto:aa@escea.com)**

GENERAL CONSTRUCTION AND FINISHES SHOWN INDICATIVE ONLY

file: D-Series FLUE Master File.dwg	scale: as shown	ecn: ECN-2155	drawing no: EDA-0006	revision: V. 02	date: 08.12.2017	drawn: MG
--	--------------------	------------------	-------------------------	--------------------	---------------------	--------------